


LIGHTING LAYOUT
 SCALE: 1/4" = 1'-0"

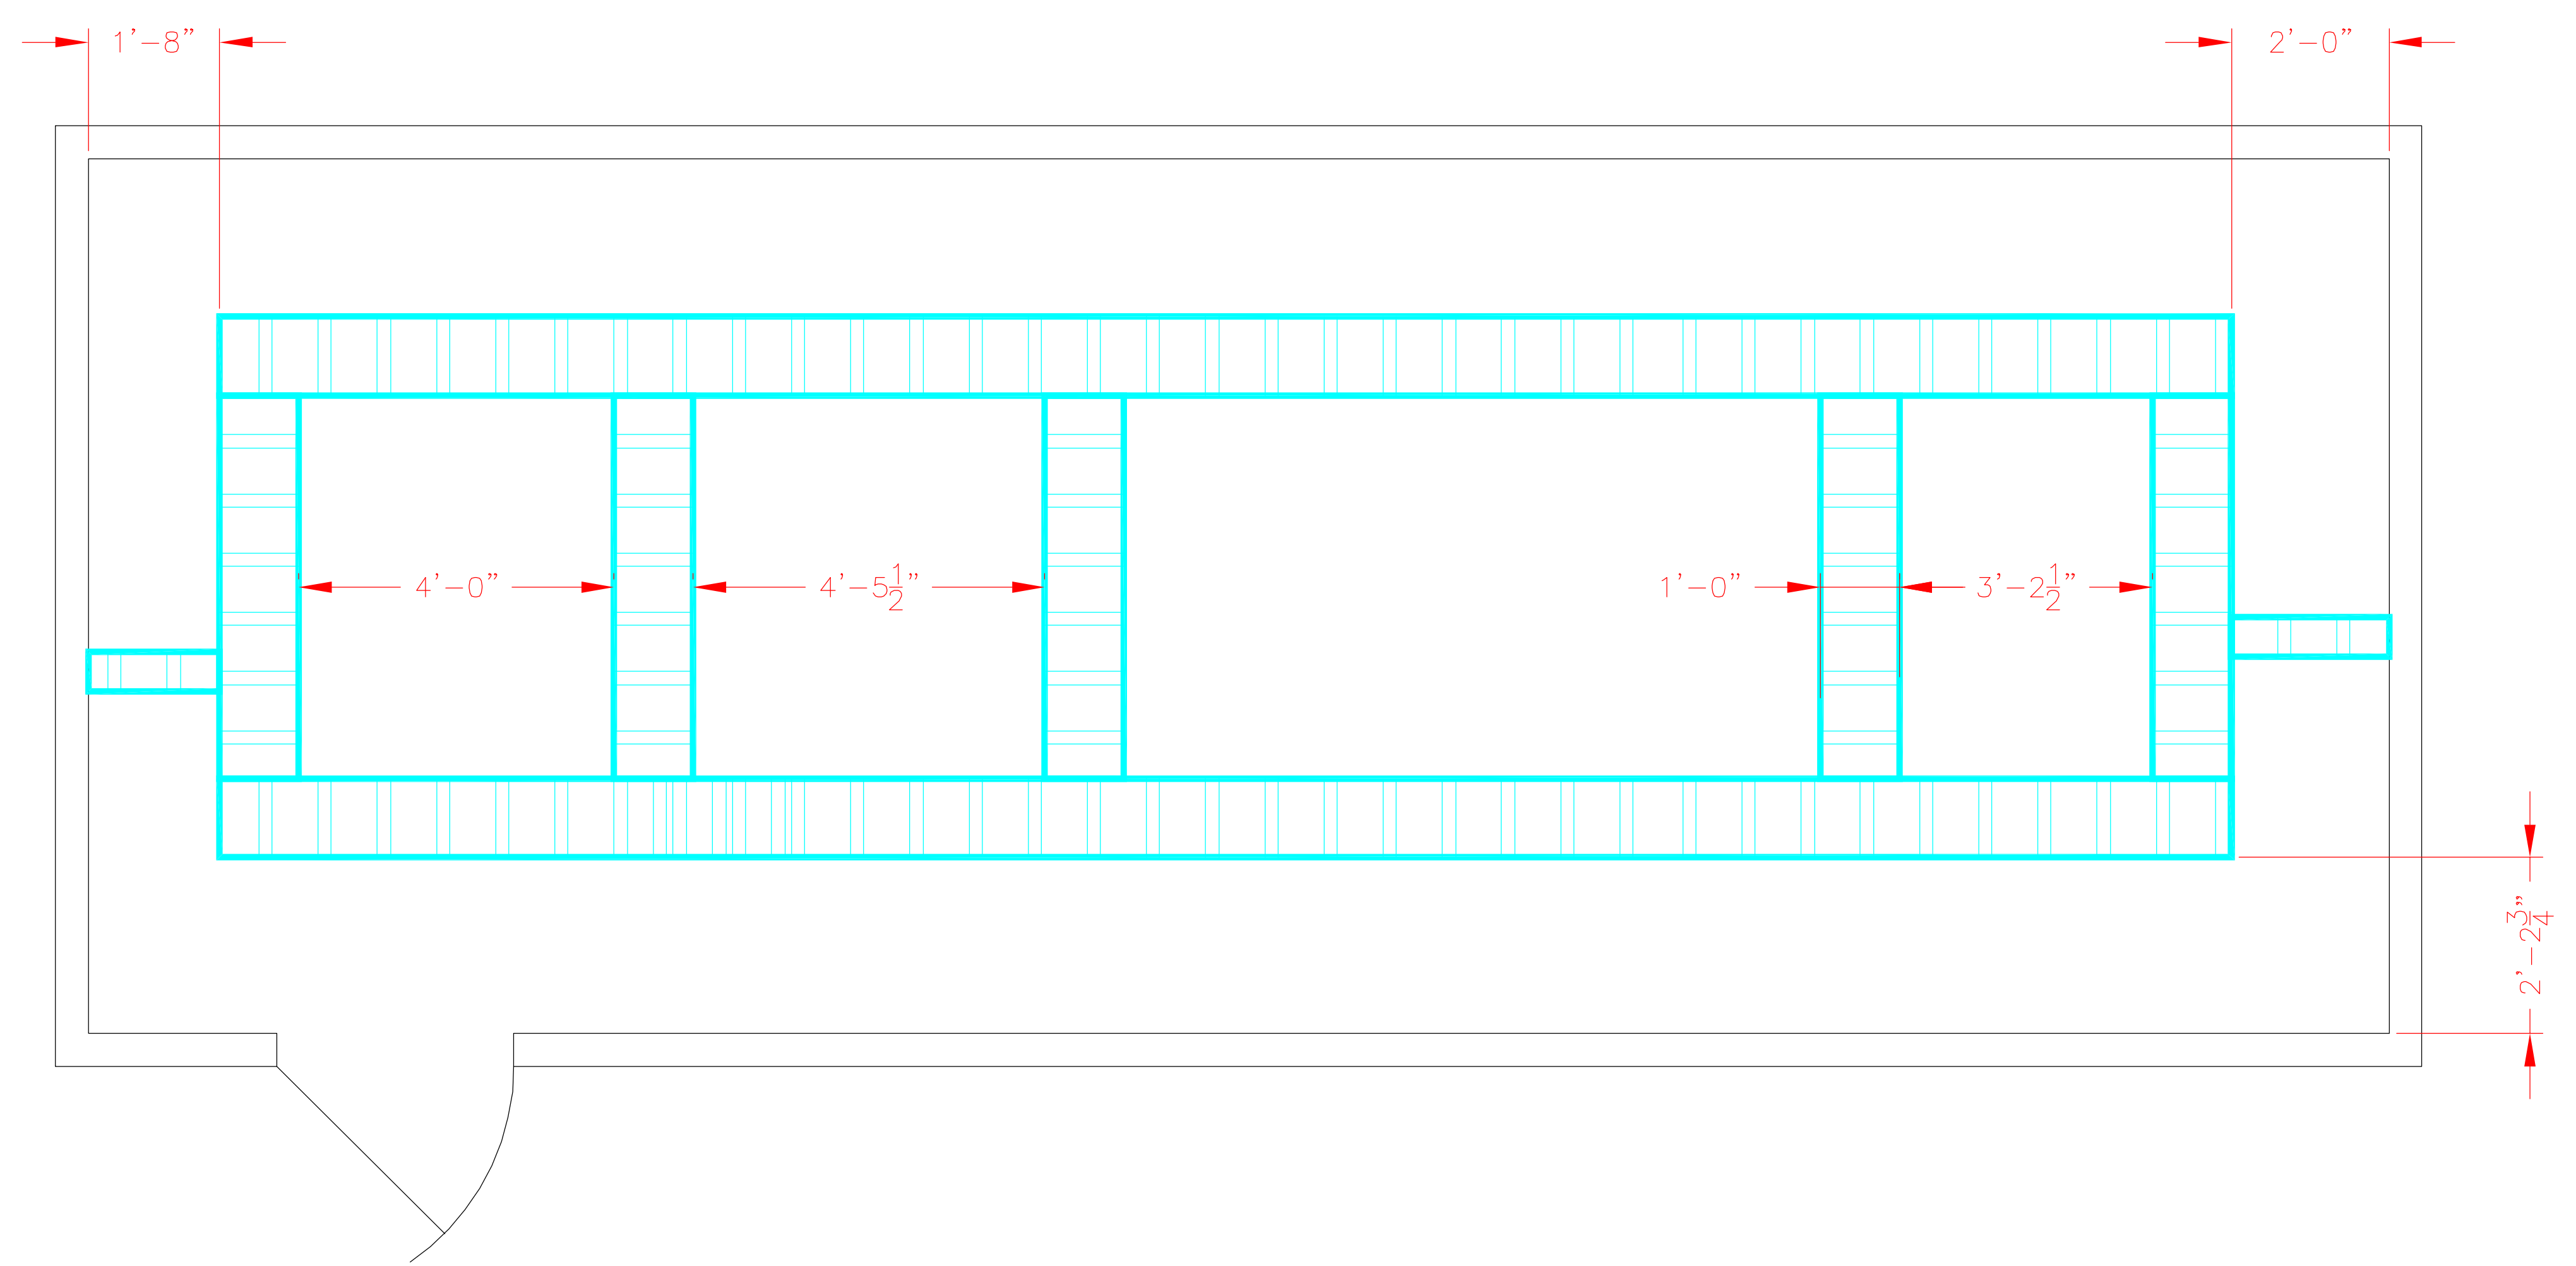

CABLETRAY LAYOUT
 SCALE: 1/4" = 1'-0"